
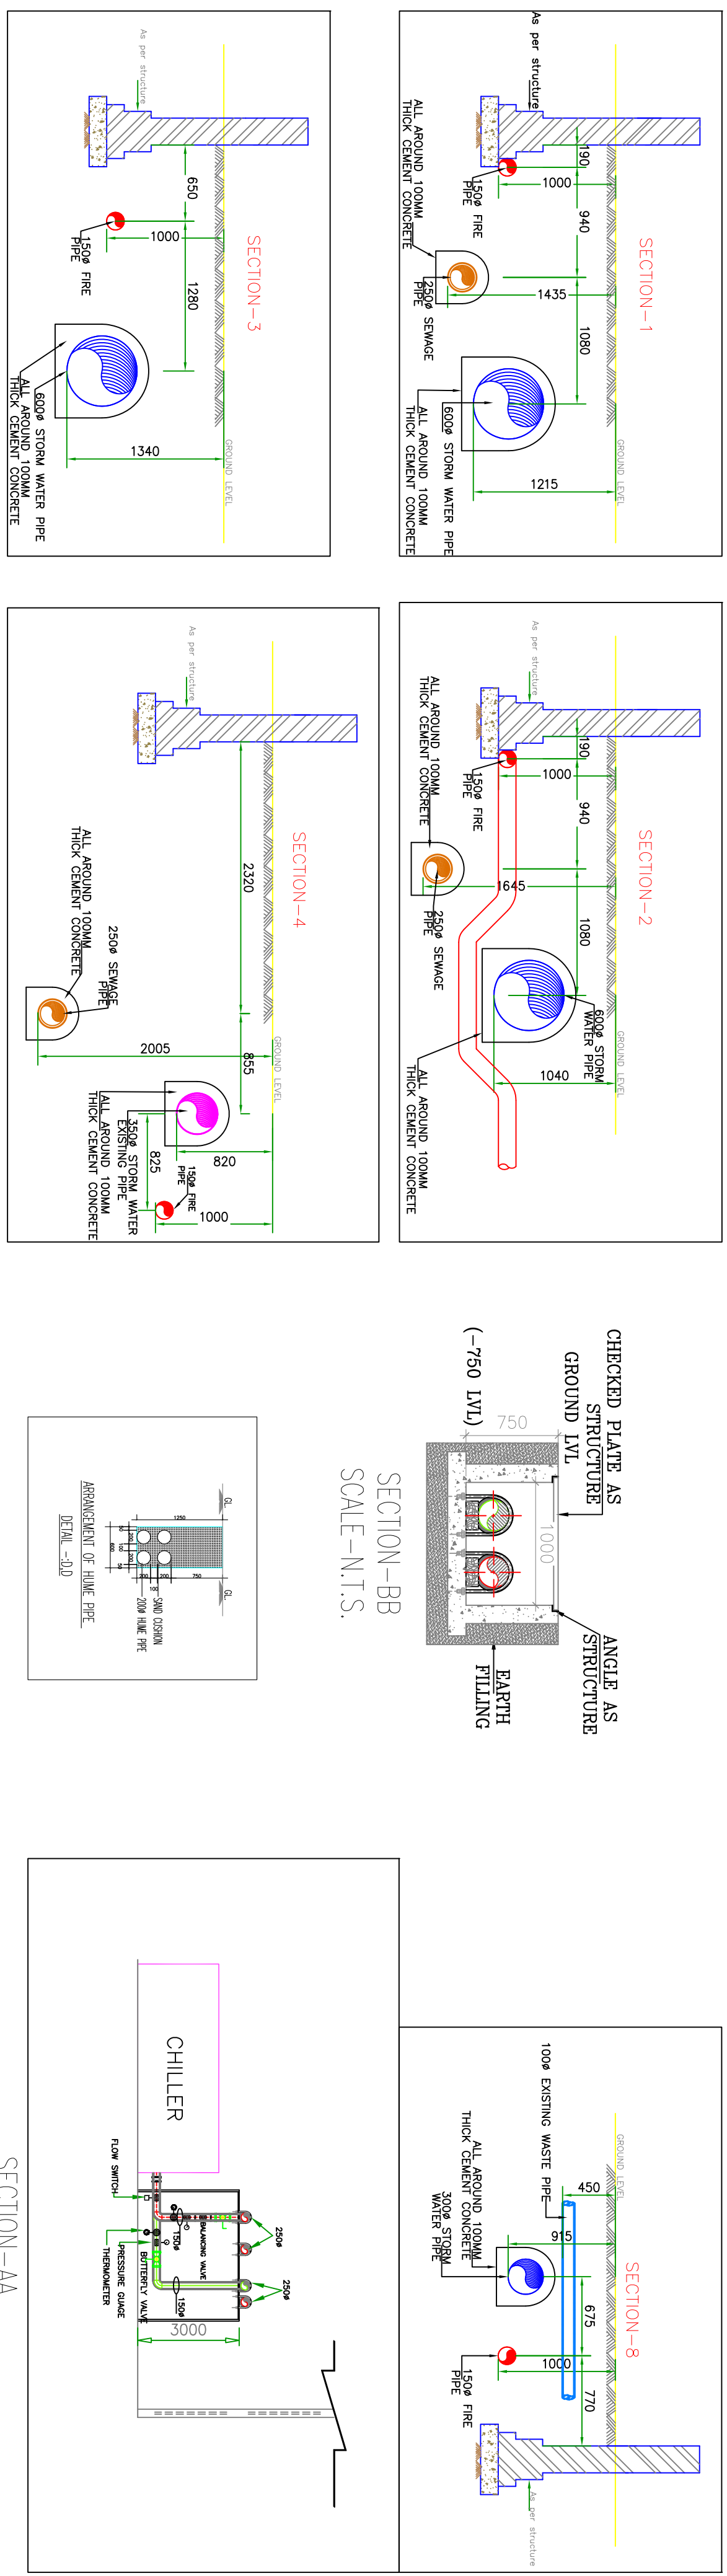
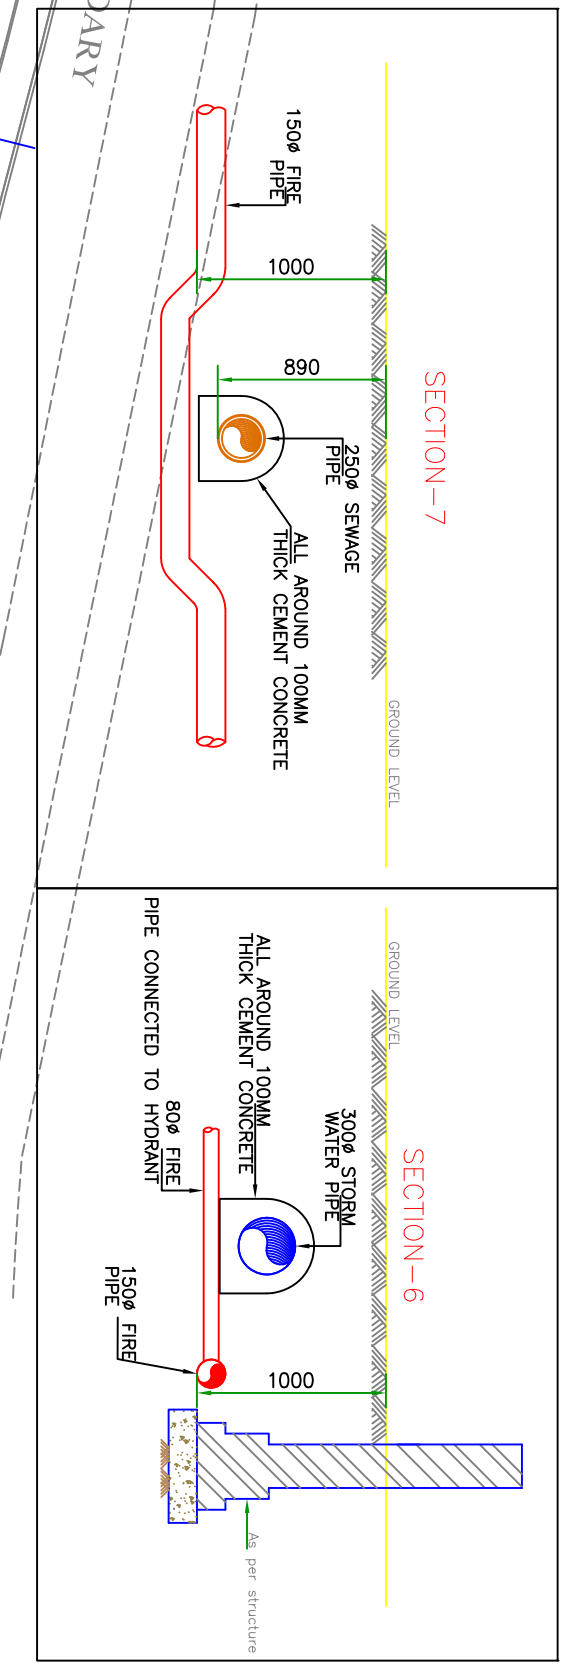


LEGEND	SYMBOL	DESCRIPTION
PROPOSED INTERNAL LIQUID WASTE		
EXISTING INTERNAL LIQUID WASTE		
PROPOSED INTERNAL SOIL WASTE		
EXISTING INTERNAL SOIL WASTE		
PROPOSED EXTERNAL SOIL WASTE		
EXISTING EXTERNAL SOIL WASTE		
PROPOSED EXTERNAL SEWAGE		
EXISTING EXTERNAL SEWAGE		
PROPOSED FIRE LINE		
EXISTING FIRE LINE		
PROPOSED STORM WATER LINE		
EXISTING STORM WATER LINE		
4000 RAIN WATER PIPE		

LEGEND	SYMBOL	DESCRIPTION
INTERNAL FIRE HOSE CABINET		
EXTERNAL FIRE HOSE CABINET		
PROPOSED FIRE LINE		
EXISTING FIRE LINE		
MAIN FIRE BRIDGE CONNECTION		
SLUICE VALVE		

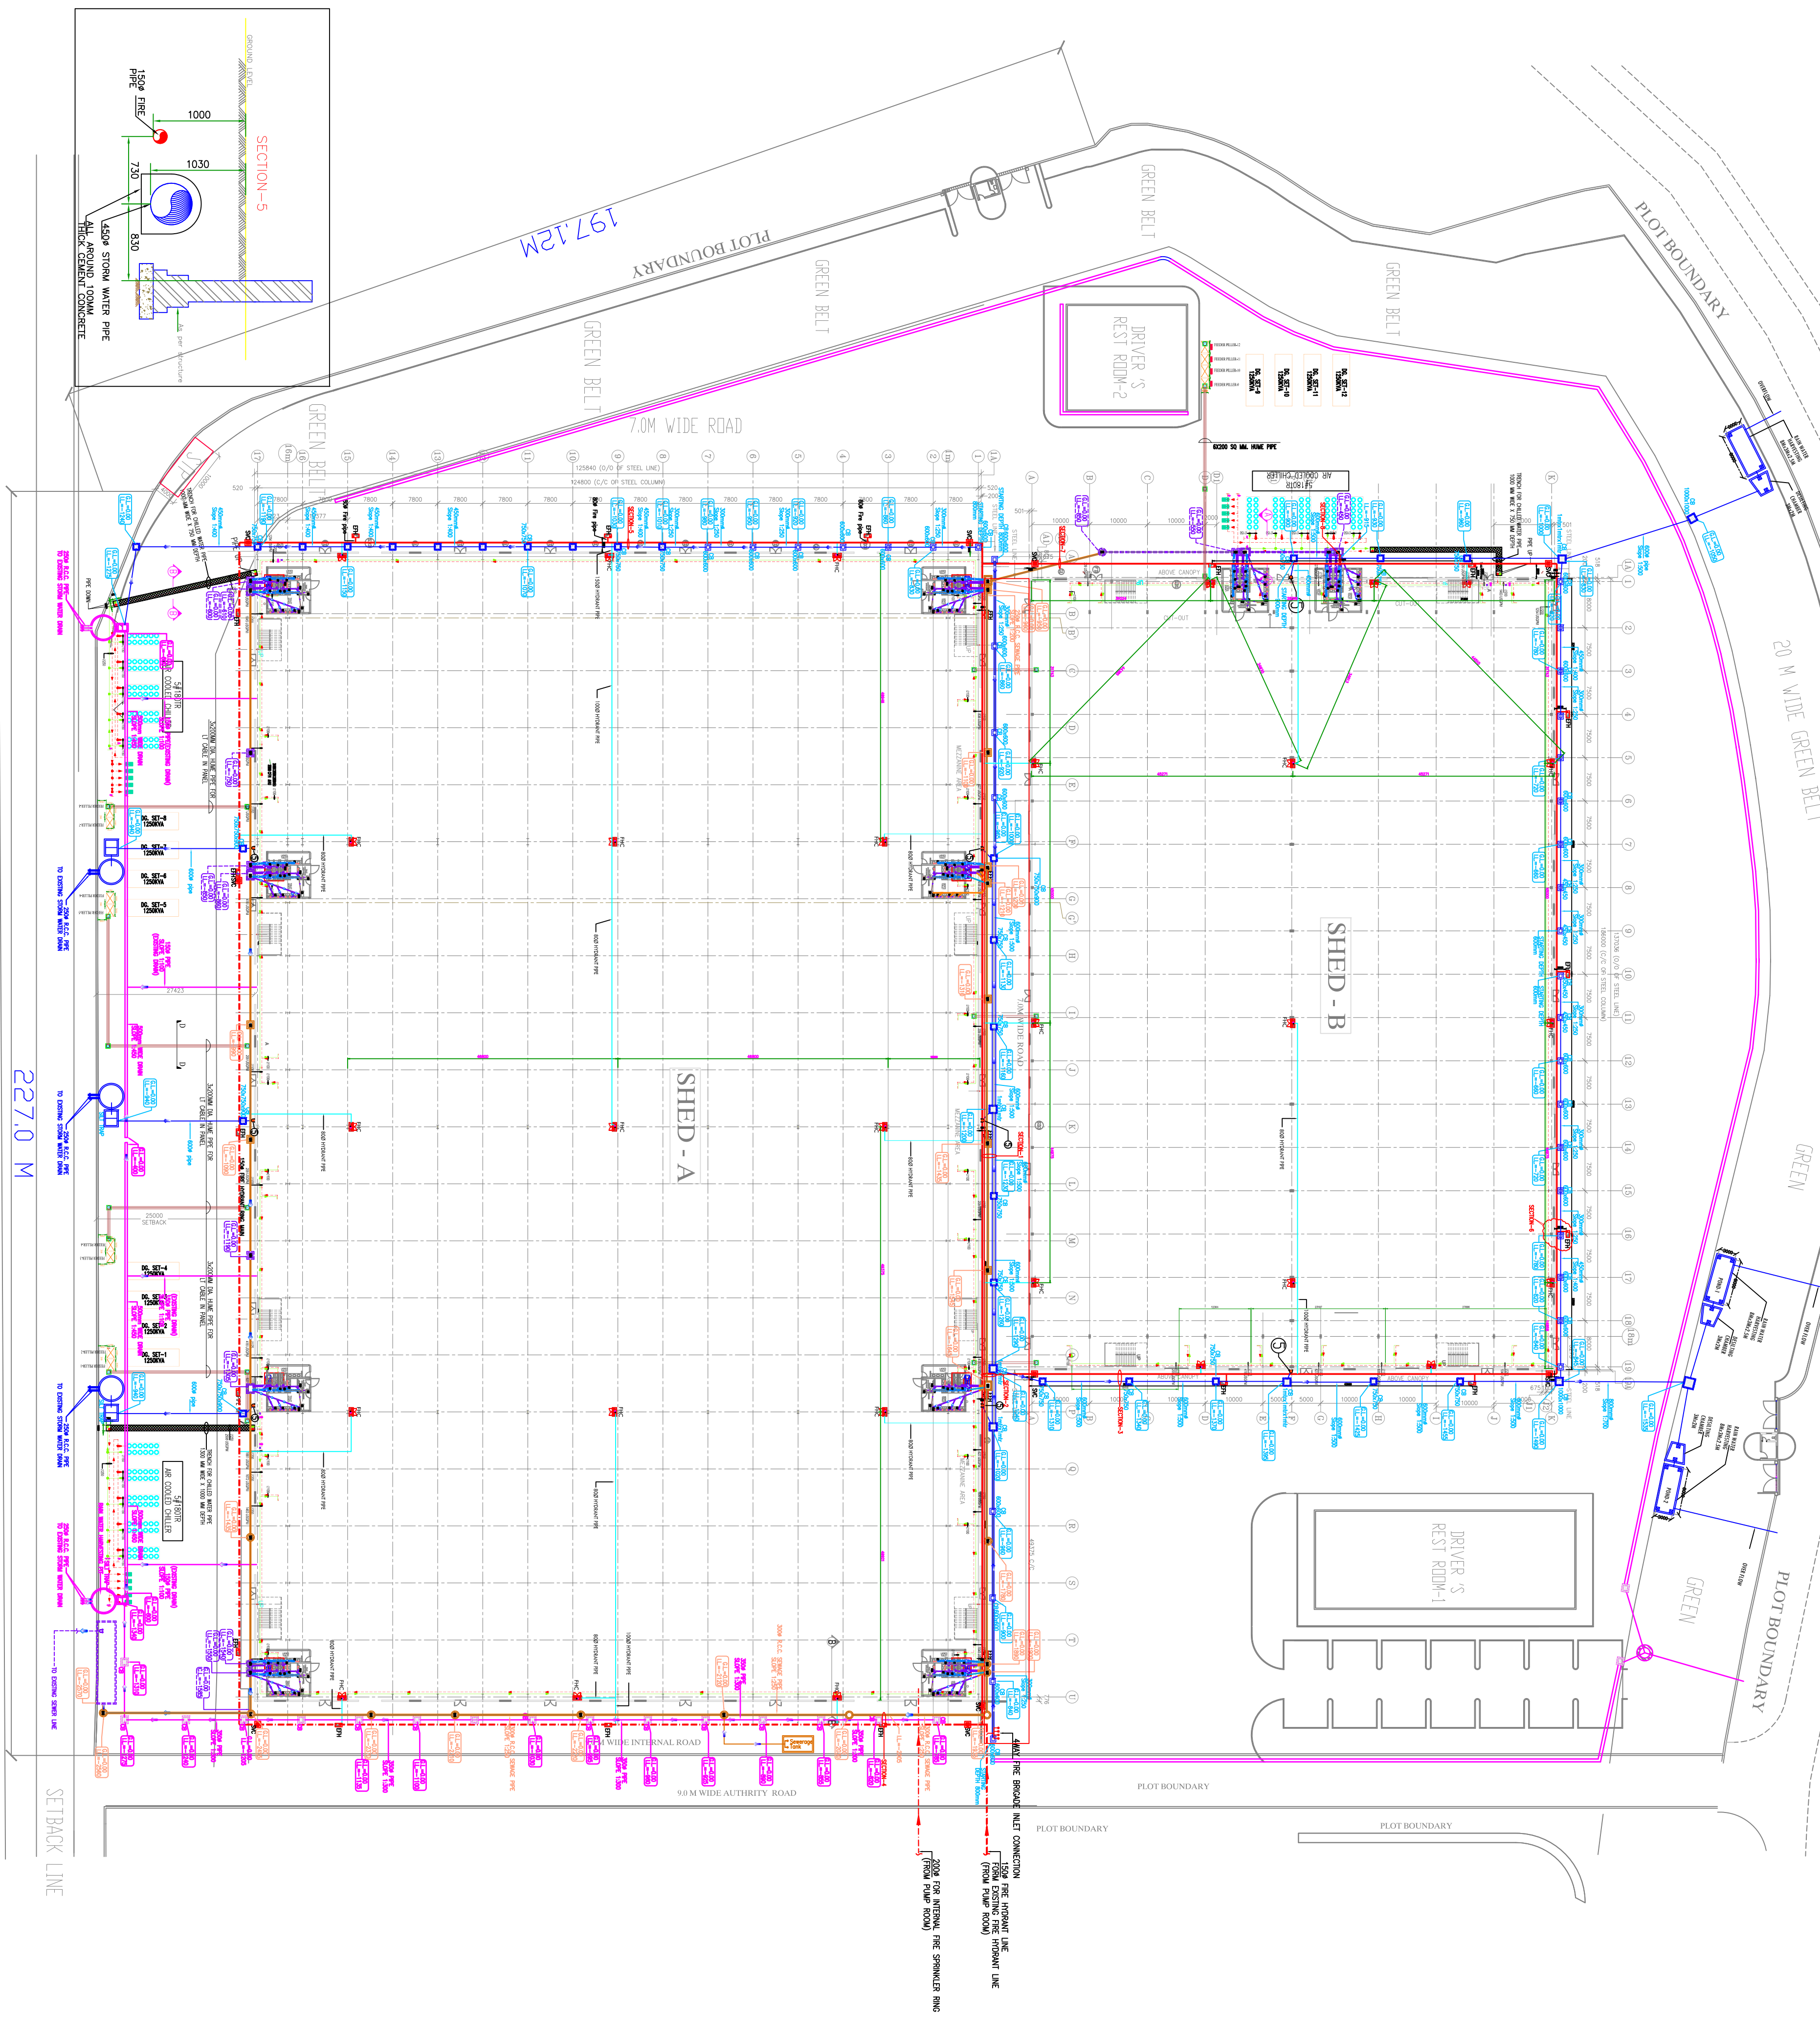

THE DRAWING IS THE PROPERTY OF THE CONSULTANT AND NOT TO BE REPRODUCED OR USED FOR ANY OTHER PROJECT WITHOUT THE WRITTEN PERMISSION.

CLIENT

INDIAN EXPOSITION MART LTD.

MARKET AND TRADE FAIR EXHIBITION CENTER

PARK 2, GATEWAY BIRLA MANSION, CHENNAI

INDIA - 600006 (I.P.)

DATE	22.04.2015	DESIGN BY	C.K.
CHECKED BY	J.H.	SCALE	1:400 (A1)

DRAWING TITLE

SITE PLAN CO-ORDINATED LAYOUT

SEMAG

Consultants Pvt. Ltd.

INDIAN EXPOSITION MART LTD.

MARKET AND TRADE FAIR EXHIBITION CENTER

PARK 2, GATEWAY BIRLA MANSION, CHENNAI

INDIA - 600006 (I.P.)